

KEY NOTES:


- APPLICABLE TO THIS SHEET ONLY
- 1. STRUCTURAL COLUMN, TYPICAL. SEE METAL BLDG DWGS
- 2. STRUCTURAL MEMBER OVERHEAD. SEE METAL BLDG DWGS
- 3. CANOPY OVERHANG ABOVE PER SCHEDULE
- 4. PENHOUSE LINE ABOVE AWNING ABOVE
- 5. CONCRETE FLOOR
- 6. EXTERIOR 3'-0" x 7'-0" STOREFRONT-TYPE GLAZED DOOR. SEE SCHEDULE AND DETAIL 7 SHEET A7.1
- 7. INTERIOR 3'-0" x 7'-0" STOREFRONT-TYPE GLAZED DOOR. SEE SCHEDULE
- 8. EDGE OF CONCRETE SLAB, S.S.D.
- 9. MASONRY WALL CONTROL JOINT, S.S.D.
- 10. CONCRETE SLAB AT CANOPY STRUCTURE. SEE CIVIL AND STRUCTURAL PLANS. SEE ELECTRICAL SCHEDULE
- 11. LEVEL CONCRETE 5/8" LANDING WITH MAXIMUM 2% SLOPE IN ALL DIRECTIONS
- 12. STONE VENEER COLUMNS, S.S.D.
- 13. SLAB DRAIN SEE CIVIL DWGS
- 14. CONTROL JOINTS

WALL TYPES


- 1. 8" R/U FACE CONCRETE MASONRY UNIT WALL WITH 5" INSULATED R-28 METAL PANEL WALL FINISH ON INTERIOR SIDE
- 2. 5" INSULATED METAL PANEL WALL, R-28
- 3. 6" LIGHT GAGE METAL STUDS AT 16" O.C. WITH R-19 BATT INSULATION. FINISH BOTH SIDES WITH 5/8" GYP BOARD. TILE FINISH ON RESTROOM SIDE PER SCHEDULE
- 4. 4" FLIGHT GAGE METAL STUDS AT 16" O.C. WITH SOLID BATT INSULATION. FINISH BOTH SIDES WITH 5/8" GYP BOARD. TILE FINISH ON RESTROOM SIDE PER SCHEDULE
- 5. 8" CMU WALL AND 4" METAL STUD FURSING AT 16" O.C. WITH R-13 BATT INSULATION AND 5/8" GYP BOARD ON RESTROOM SIDE. TILE FINISH PER SCHEDULE
- 6. 5" INSULATED METAL PANEL WALL (R-28) WITH 4" METAL STUDS AT 16" O.C. AND 5/8" GYP BOARD ON RESTROOM SIDE. TILE FINISH PER SCHEDULE

LEGEND

- 1. CMU WALL
- 2. METAL STUD WALL
- 3. INSULATED METAL PANEL WALL
- 4. WALL TYPE SYMBOL. SEE WALL LEGEND, THIS SHEET
- 5. EXTERIOR WINDOW TYPE SYMBOL. SEE SHEET A6.0
- 6. DOOR TYPE SYMBOL. SEE SHEET A6.0
- 7. MASONRY OPENING

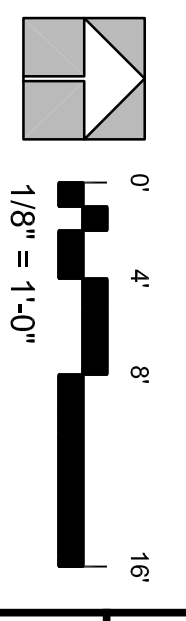

FLOOR PLAN

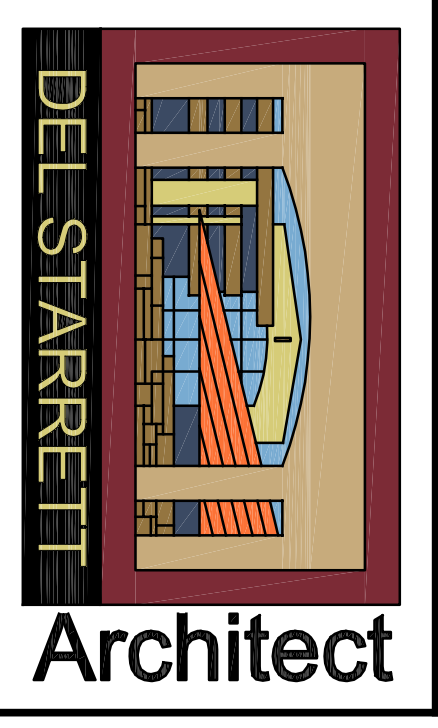

3663 NORTH LAUGHLIN ROAD, SUITE 207
 SANTA ROSA, CALIFORNIA 95403
 PHONE: (707) 526-9645



Kunde Barrel Storage
 9825 SONOMA HIGHWAY
 KENWOOD, CA

12/23/19	BLDG DEPT SUBMITTAL 1	
REV	DATE	DESCRIPTION
1518		
CAD DWG FILE: x24x36 tb.dwg		
DRAWN BY: CRS		
SCALE: 1/8"=1'-0"		
© Copyright 2019 Del Starrett Architect		
SHEET TITLE		
FLOOR PLAN		
SHEET NUMBER		
A2.0		